



LEGEND

NOTE: Not all devices and designations in legend may apply to this building

- FP** Fire Alarm Pull (FP)
- SP** Standpipe (SP) (with or w/o a hose)
- WS** Warden Station (WS) (Fire phone or phone jack)
- FCS** Fire Command Station (FCS) (See Ground Floor)
- FACP** Fire Alarm Control Panel
- Fire Dept. Connection** (1st Fl. & Site Plan)
- SV** Sprinkler Valve (SV)
- SPV** Standpipe Valve (SPV)
- DWV** Domestic Water Valve

EXIT Evacuation Route

Furniture/ Equip. (furniture/ equipment/ removable partitions)

Permanent Partition (non-removable permanent partitions)

Fire Barrier (fire rated enclosures that are fire stopped; e.g. permanent partition walls of dwelling, corridors, & mech. equip. rooms)

In-Building Relocation Areas (IBRAs)


NO.	DATE	NAME	ISSUED/ COMMENTS
1	02.11.15	AR	ISSUED FOR REVIEW AND FILING

Drawn By: HZ/AR Checked By: AT

BUILDING ADDRESS:
49 W. 27th Street
New York, NY 10001

DRAWING TITLE:
FL-9
9th Floor

SURVEY BY: AR SURVEY DATE(S): 12.30.14

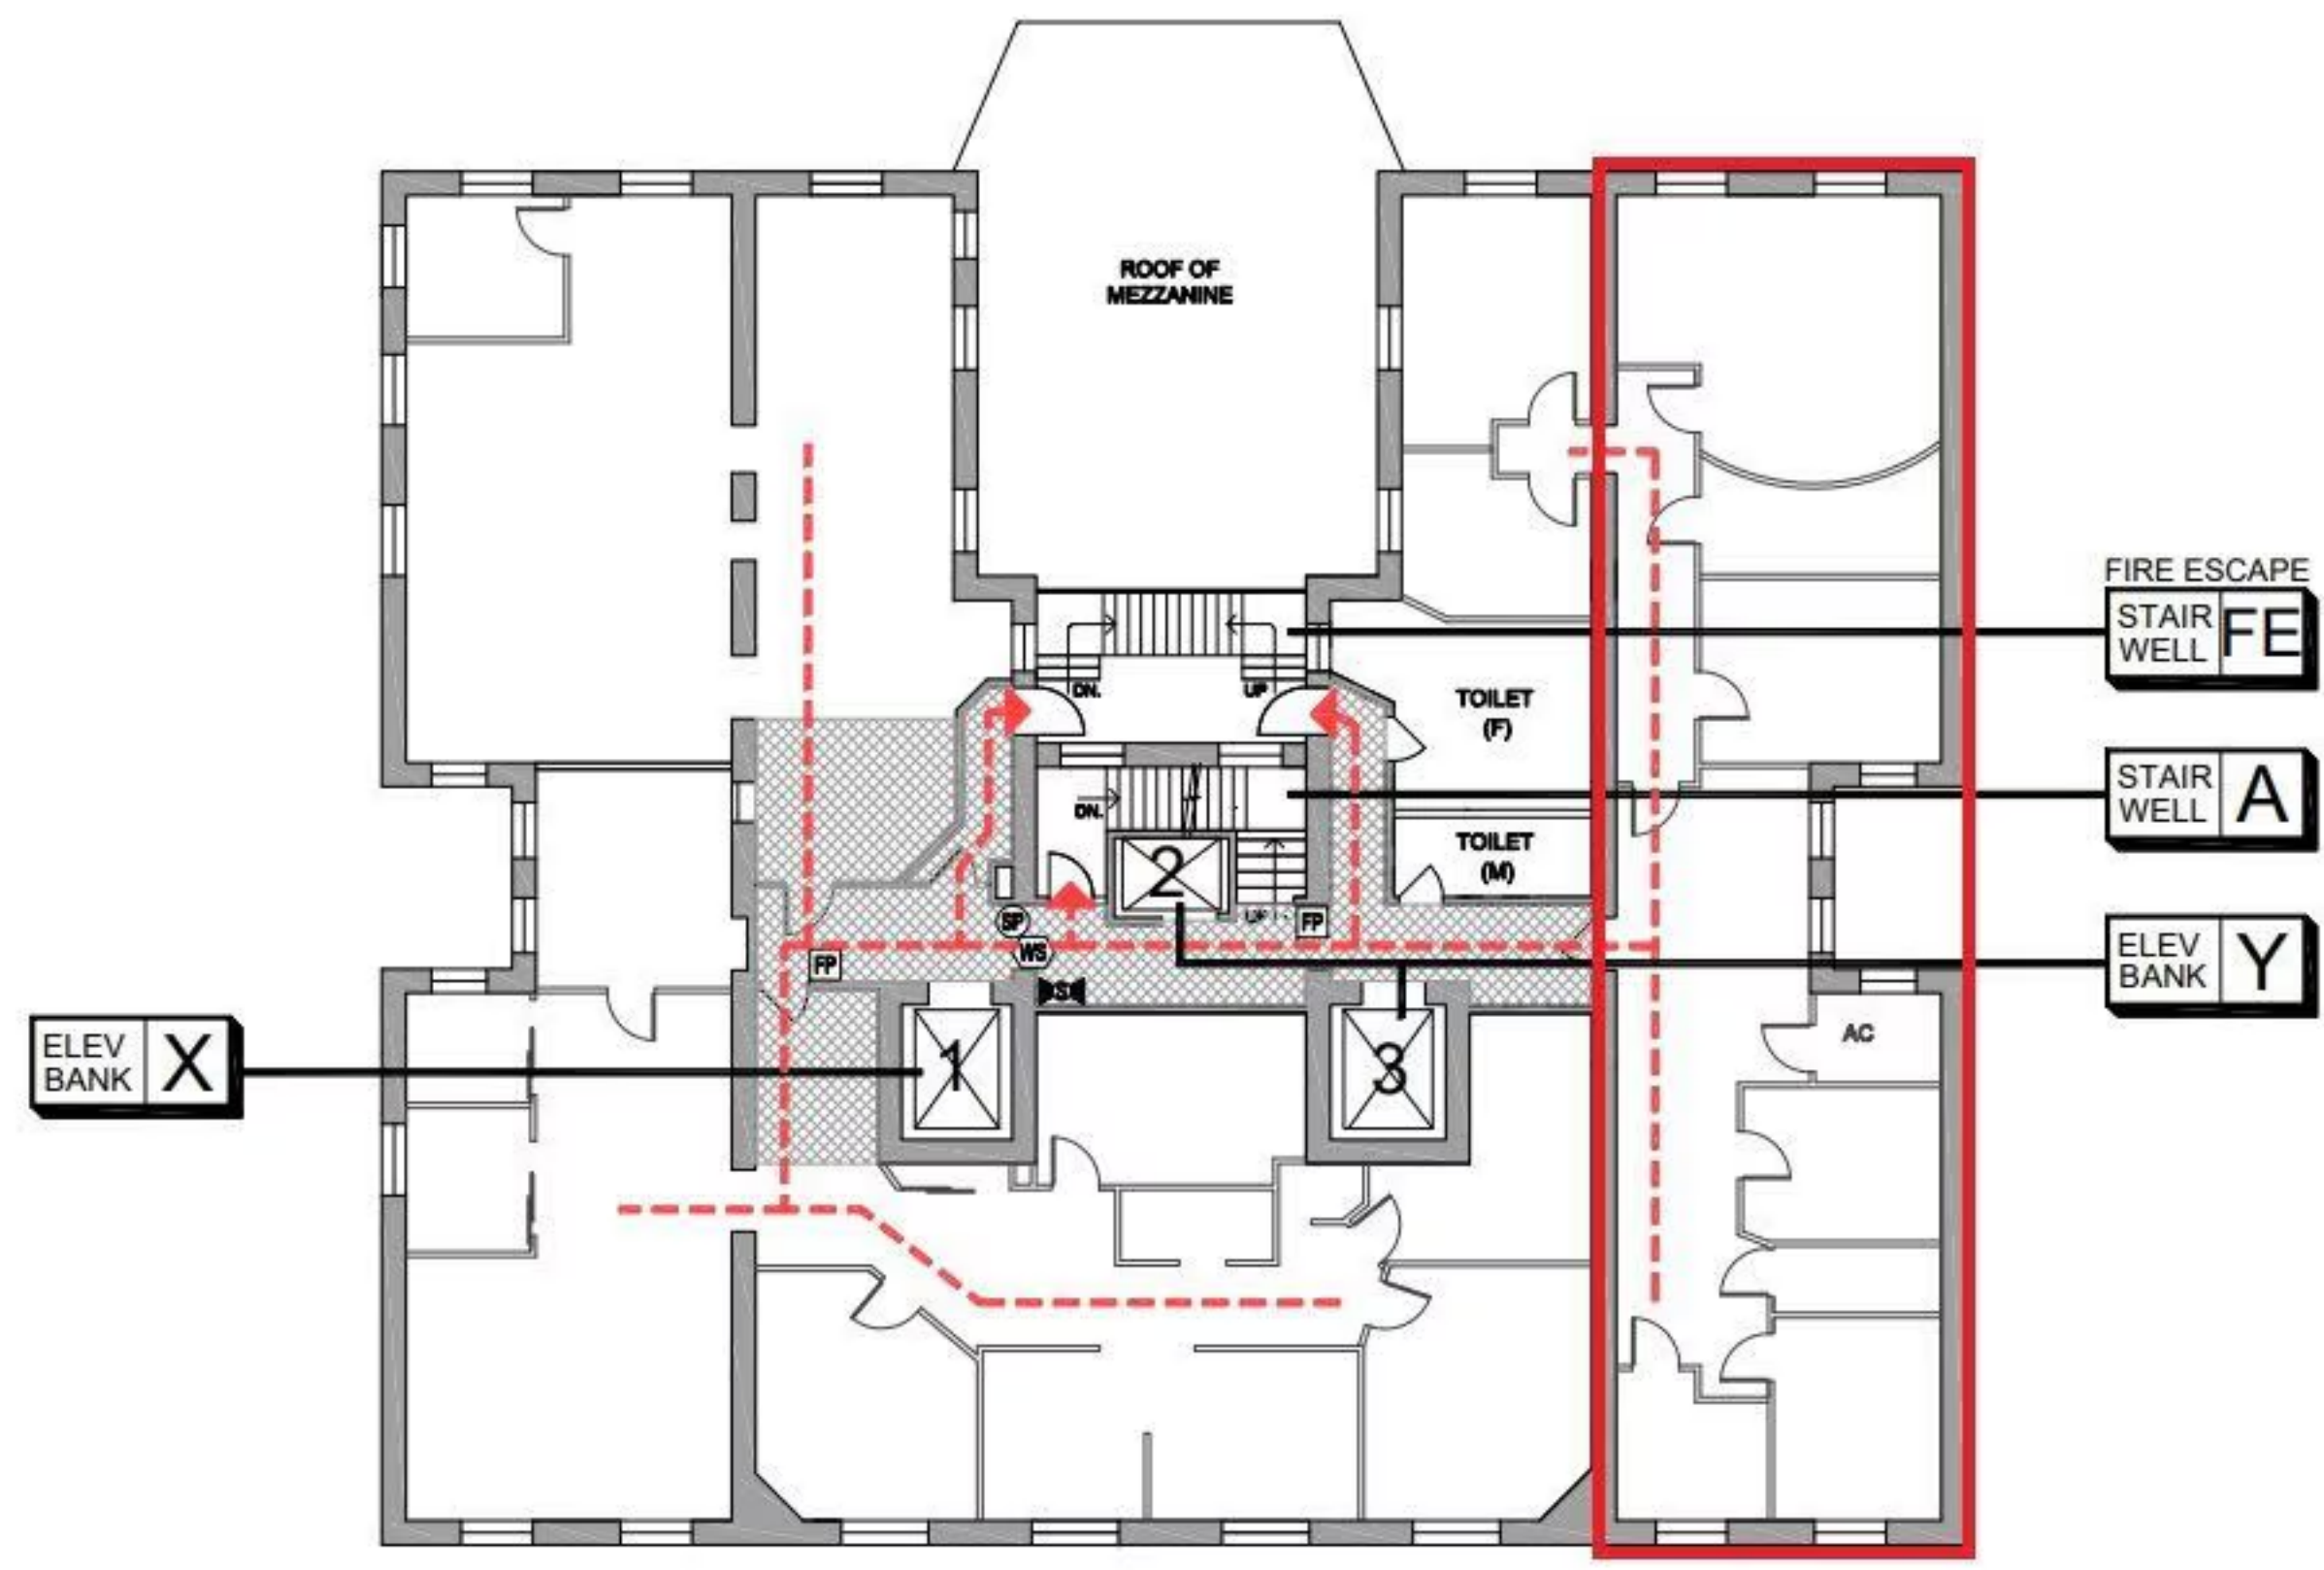

WEST 27TH STREET

NOTE: FULL SPRINKLER COVERAGE