

SEAL

NOT FOR CONSTRUCTION

DOB STAMP

DOB SCAN

ISSUED / REVISED

NO. DATE DESCRIPTION

PROJECT #18033
244 FIFTH AVE 6 FL
244 FIFTH AVE, 6 FL
NEW YORK, NY


DRAWING TITLE
PLUMBING PLAN

DATE ISSUED
4/23/2018

DRAWING NUMBER

P-101.00

.. OF

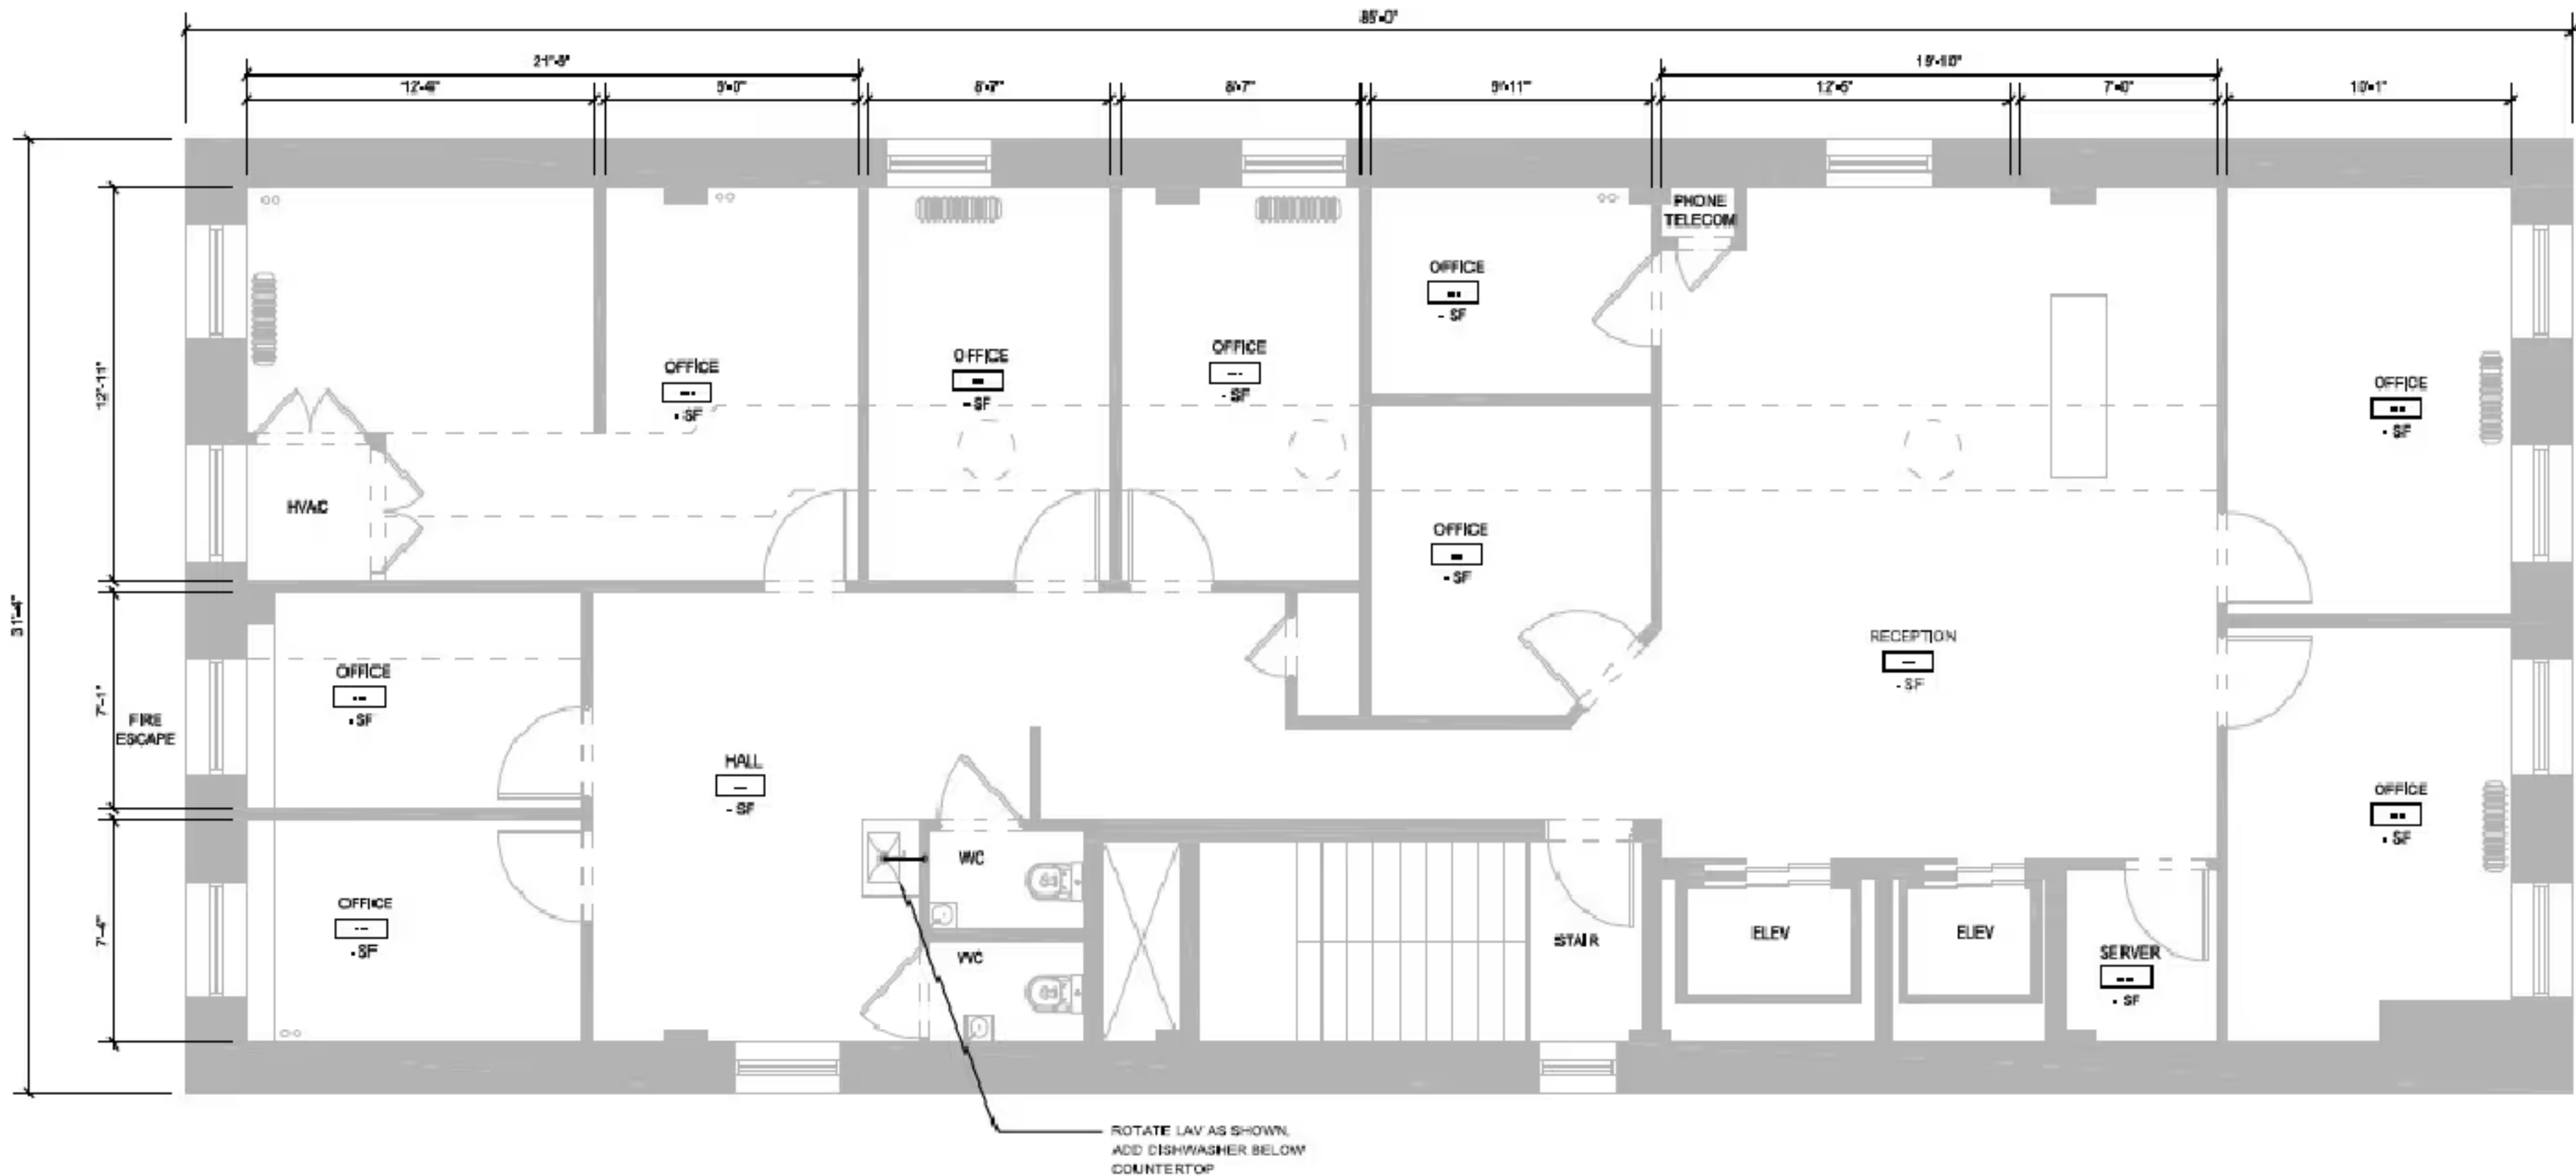

01 PLUMBING PLAN
1/4" = 1'-0"

